

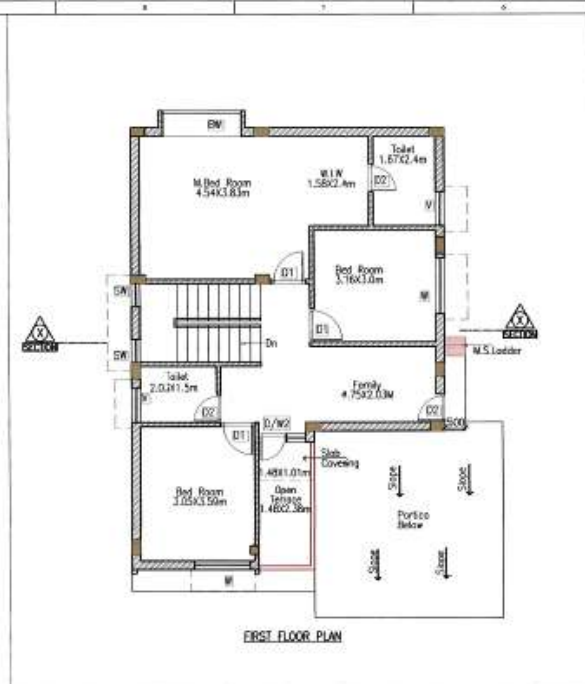
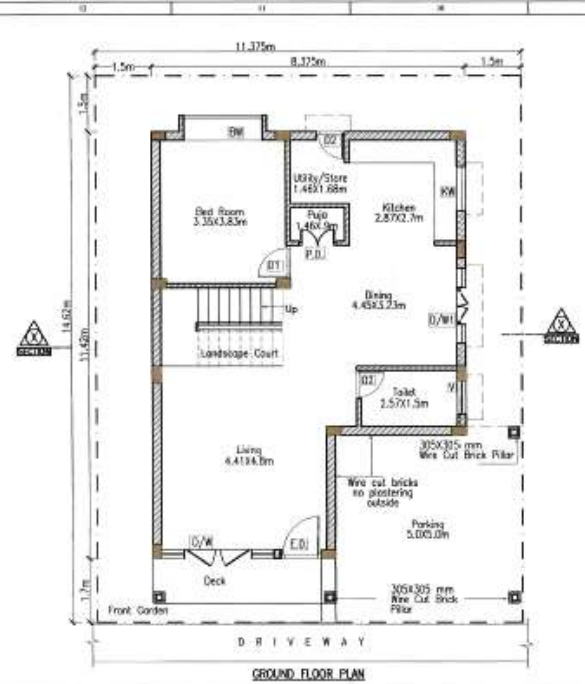


THIS DESIGN AND DRAWINGS ARE THE SOLE PROPERTY OF ACS DESIGN CONSULTING PVT LTD AND SHALL NOT BE PLACED, COPIED, REPRODUCED, MODIFIED, USED IN ANY OTHER MANNER WITHOUT THE WRITTEN CONSENT OF THE CONSULTANTS.

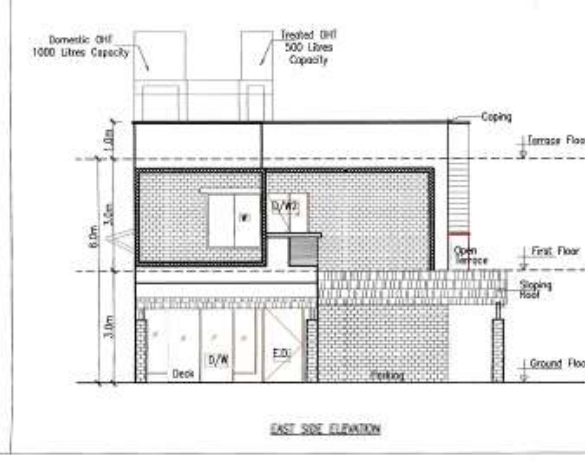

SCHEDULE OF OPENINGS		
SL. NO.	W/O	Size (sq. m)
DOORS		
1	ED	1.1x2.1
2	D/W	1.8x2.1 + 0.6+0.6x1.85
3	D/W	1.0x2.1 + 0.5+0.5x1.85
4	D/W	0.75x2.1 + 0.3x1.85
5	DI	0.9x2.1
6	D	0.75x2.1
7	PD	1.0x2.1
WINDOWS		
8	W	1.5x1.5
9	W	1.2x0.9
10	SW	0.6x1.5
11	SW	2.1x1.65
12	V	0.9x0.6
AREA STATEMENT		
FLOOR	BUILT UP AREA IN Sq.m	
GROUND FLOOR	84.62	
FIRST FLOOR	83.05	
TOTAL	167.67	

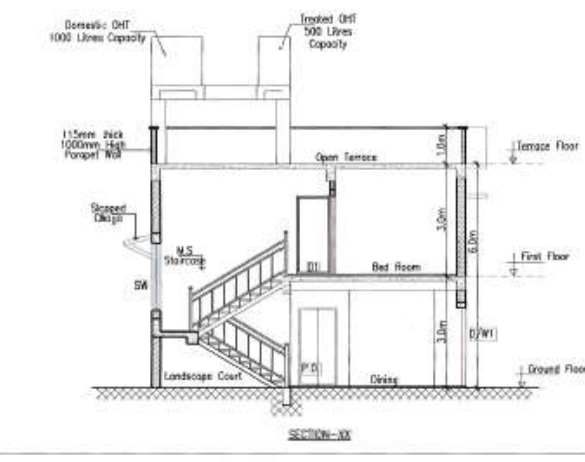

HOUSE NUMBERS - TYPE: T-1 A
37-43, 72-75, 80-83, 88-89,
92-95, 100-103, 132-134, 138-140,
144-146, 150-152, 156-161, 166-170



P3	FOR APPROVAL	21.08.2019	RASHMI	DIYA	CRS
P2	FOR APPROVAL	04.12.2018	SANKALPA	DIYA	CRS
P1	FOR APPROVAL	19.08.2019	SANKALPA	DIYA	CRS
P0	FOR APPROVAL	20.05.2018	NEHA	DIYA	CRS
REV NO	DETAILS	DATE	DRAWN	DESIGNED BY	CHECKED BY
AUTHORIZED CLIENT:					
 BANGALORE DEVELOPMENT AUTHORITY OFFICE OF THE EXECUTIVE ENGINEER T.CHOWDAH ROAD, KUMARAPARK WEST, BANGALURU - 560020					
CONSTRUCTION AGENCY:					
 HOMBALE CONSTRUCTION AND CONSULTANCY PVT LTD #1312, 11th MAIN, VAYNAPUR, BANGALORE-560045 BANGALORE PH NO : 0802350445 Email : contact@hombale.com					
ARCHITECTURAL AND STRUCTURAL CONSULTANTS :					
ACS DESIGN CONSULTING PVT LTD "NEHA", #1150, 4th FLOOR, 12th CROSS, 1st PHASE, 1st STAGE BEHIND SIDDAGANGA PUBLIC SCHOOL CHANDRA LAYOUT BANGALURU 560 072 KARNATAKA INDIA Mob: +91-098863-12271, +91-094480-64921 E-mail: acsdesign@acsdesign.biz Website: www.acsdesign.biz					
PROJECT TITLE:					
PROPOSED CONSTRUCTION OF 1 BHK, RESIDENTIAL VILLAS, RECREATION CENTER AT SURVEY NO 35, HUNNIGORE, DASARAPURA HOBLI, BANGALORE, NORTH TALUK.					
DRAWN BY:		SANKALPA			
DESIGNED BY:		DIYA			
CHECKED BY:		C.RAVISHANKAR			
DRAWING TITLE:					
FLOOR PLANS, SECTION & ELEVATION 4BHK EAST FACING VILLA (T-1A) [11.375mX14.62m]					
SCALE: 1:100 & 1:200		SIZE: A2		JOB NO: 452	
DATE: 19.08.2019		DRAWING NUMBER		REV	
ACS/452/4BHK/T-1A/SP-01				P3	